


Floor Plan.....

Doors / Window	
D1	210cm x 90cm Flush Doors, 40mm semi-solid, stained teak veneer finish with Meranti lipping & door frame, fitted with 3 brass hinges, rubber door stop & 'Unlon' knoblock with 3 keys
D2	200cm x 90cm Flush Doors, 40mm semi-solid, stained teak veneer finish with Meranti lipping & door frame, fitted with 3 brass hinges, rubber door stop & 'Unlon' knoblock with 3 keys
D3	180cm x 70cm Flush Panel Doors / water proof fitted with bathroom Indicator lock
W1	100cm x 100cm Aluminium framed sliding window, weather seals, 6mm plain glass with Venetian blinds

Fittings & Equipments	
-	1ea. GRP Fibreglass Shower Tray with vinyl curtain
-	1ea. Western WC with Flushtank & Flexible Washing Hose
-	1ea. Wash Basin with flick mixer
-	1ea. St. Steel Sink/Single Bowl with high-neck Mixer Tap
-	1ea. Water Heater (Capacity 50 Ltrs.)
-	2ea. Venetian Blinds
-	2ea. 1.5-Tons/18000 Btu-hr. Aircond. window unit 'Carrier'

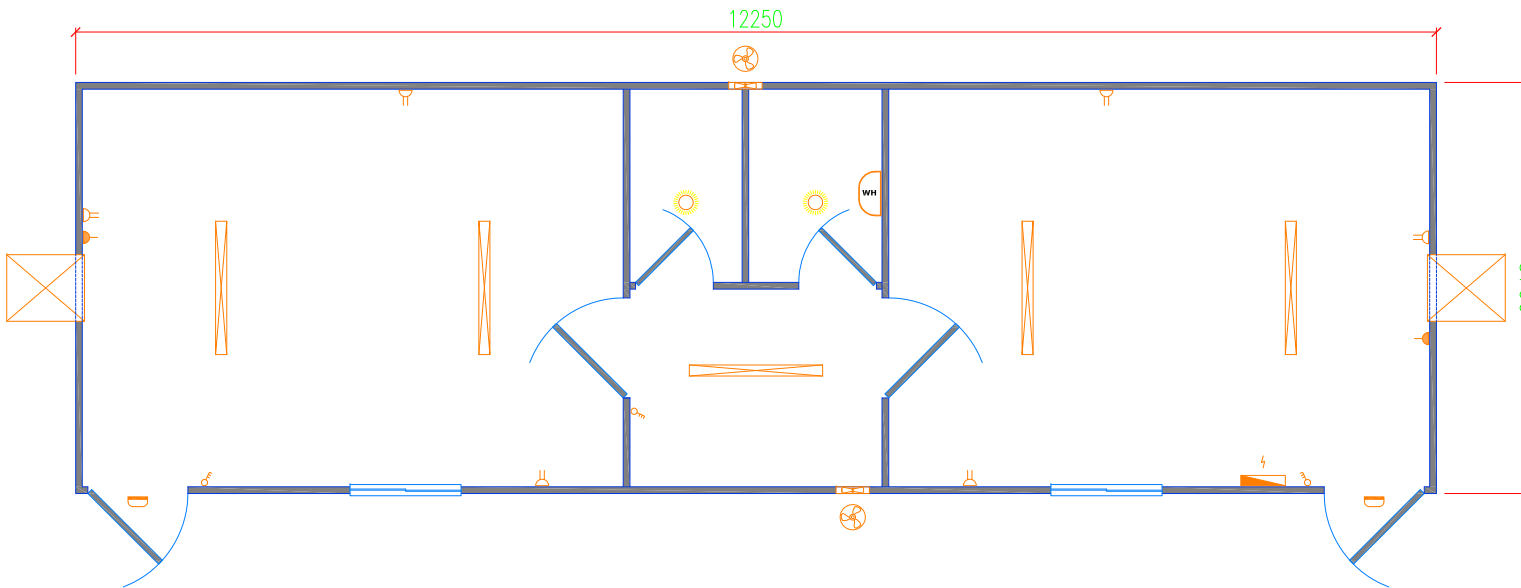

Electrical Plan.....

LEGEND	
	Single, Double, Triple Gang Switches
	13A Double Switched Socket
	15A Single Switched Socket
	32A Weatherproof AC Isolator
	Bulkhead Light IP54
	2x36W Double Fluorescent Light Fixture
	26W Energy saving Down Light, Mirror Finishing
	Distribution Panel
	15cm Exhaust Fan with auto shut-off louvers
	Window Air-Conditioner Unit
	Water Heater 50 Ltrs.

CONTRACTOR:

MODEST COMPANY

P.O. BOX : 5741
DUBAI, U.A.E
JEBEL ALI Free Zone

TEL: 04-8814786
FAX: 04-8812786



CLIENT:

Project Title:

40' x 12'
2 Room+Toilet, Shower & Pantry Cabin

Date: 17-07-11

Drawing No:

PA134-01

Size: A4


Drawing Name:

Floor + Electrical Plan


Original Scale: n.t.s.

Revision:

Designed: mhz.

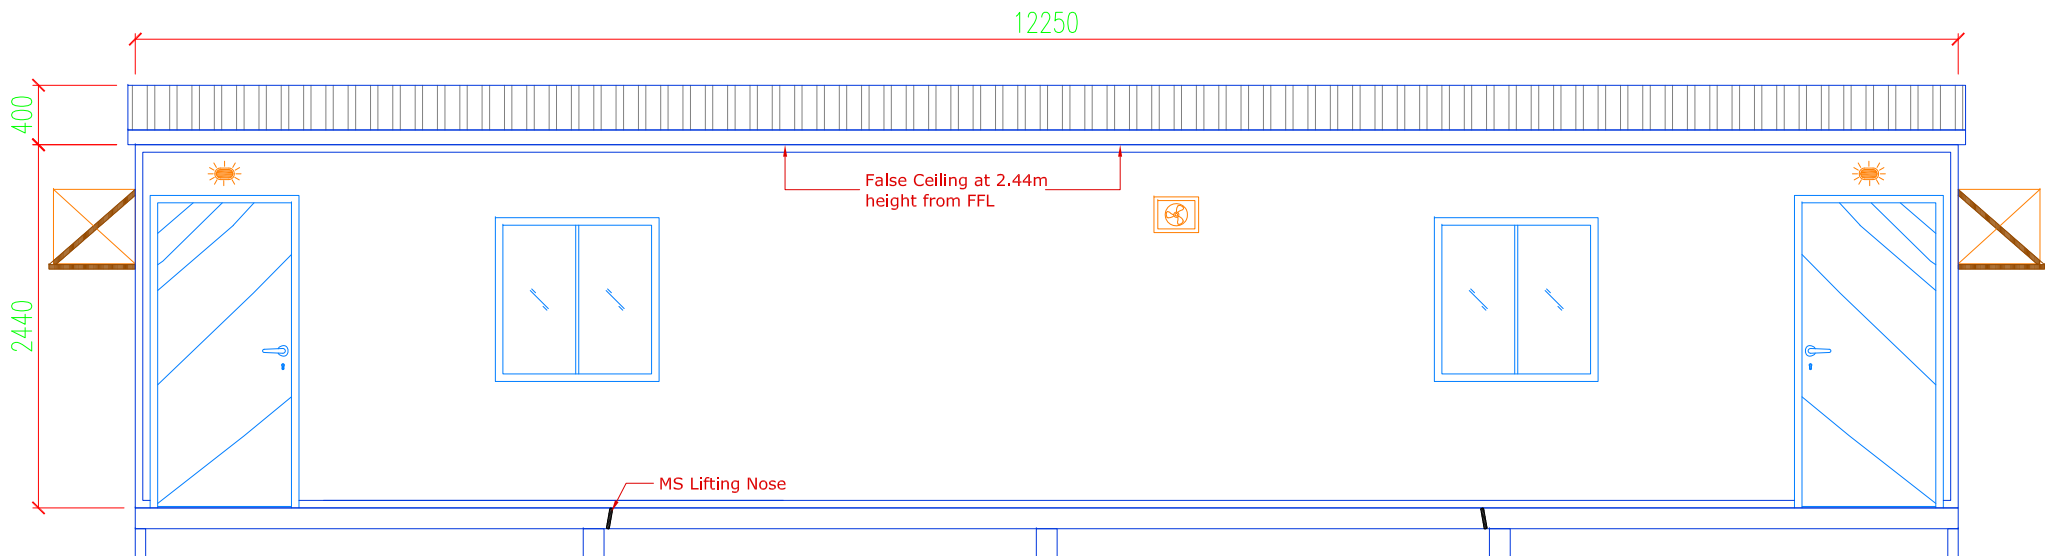

Front Elevation

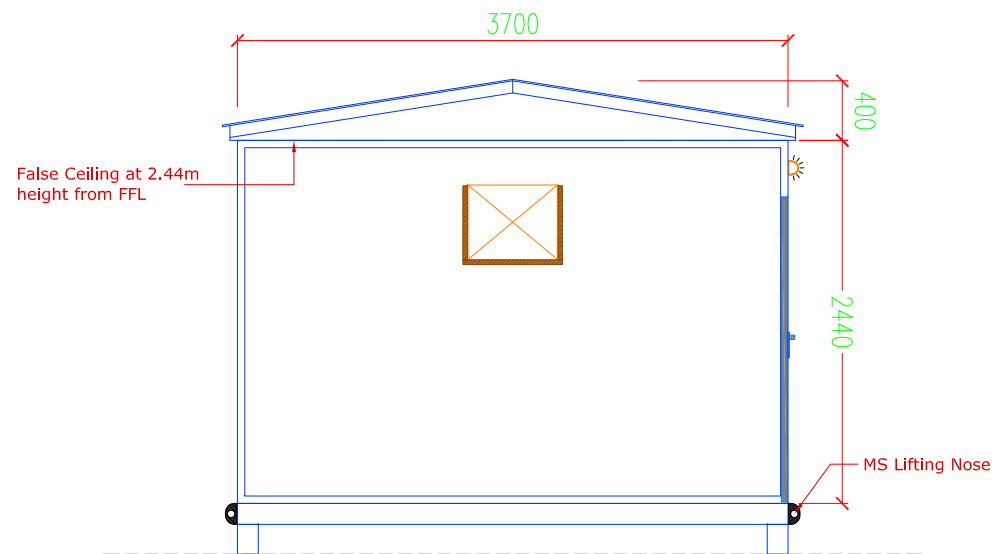

Side Elevation

SUPPLIER :

MODEST COMPANY

P.O.BOX : 5741
DUBAI, U.A.E
JEBEL ALI Free Zone

TEL: 04-8814786
FAX: 04-8812786



CLIENT :

Project Title:

40' x 12'
2 Room+Toilet, Shower & Pantry Cabin

Drawing Name:

Elevations

Date:

17-07-11

Size:

A4

Original Scale:

n.t.s.

Designed:

mhz.

Drawing No:

PA134-02

Revision:

